


# Minneapolis Convention Center - Hall A

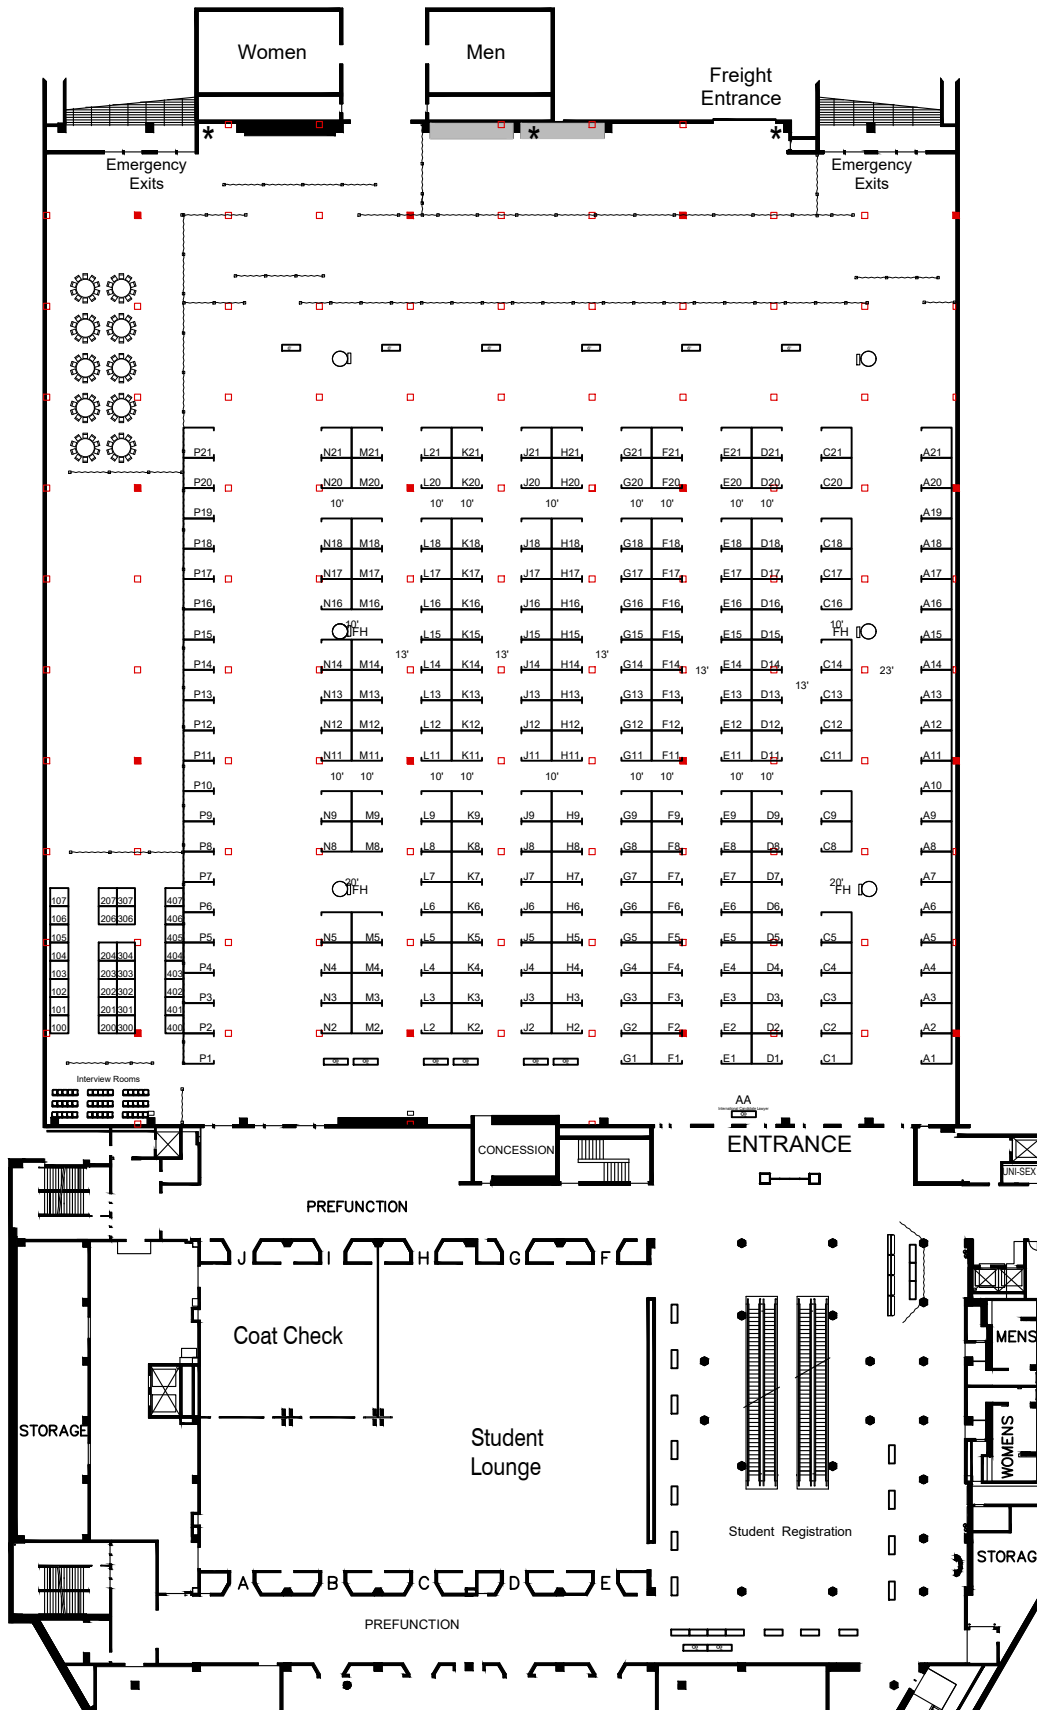

**LEGEND**

- FH - Fire Hose Cabinet
- ▭ - 9'-6" Low Ceiling Height
- ▭ - Required Safety Zone (Min. 15' Clearance)
- - Electrical
- - Electrical, Water & Drain
- ★ - Gas Connection (back wall only)

Every effort has been made to ensure the accuracy of all information contained on this floor plan. However, no warranties, either expressed or implied are made with respect to this floor plan. If the location of building columns, utilities or other architectural components of the facility is a consideration in the construction of an exhibit, it is the sole responsibility of the exhibitor to physically inspect the facility to verify all dimensions and locations.

## MN Private College Job&Internship

2/24/22


Facility: MN CC	Drawn By: Jocie Braaksma
City & State: Minneapolis, MN	Show Number: 13327-22
Room Location: Hall A And Lobby A	Revised: 1/27/2022 2:33 PM
A.E. Mike Marigold	Drawing File: 13327_22 MN Private College Job & Internship r4.dwg

Legend:

Inventory as of 01/27/2022

Dimension	Size	Qty	SqFt
6'x6'	36	30	1,080
10'x10'	100	236	23,600
<b>Totals:</b>		<b>266</b>	<b>24,680</b>



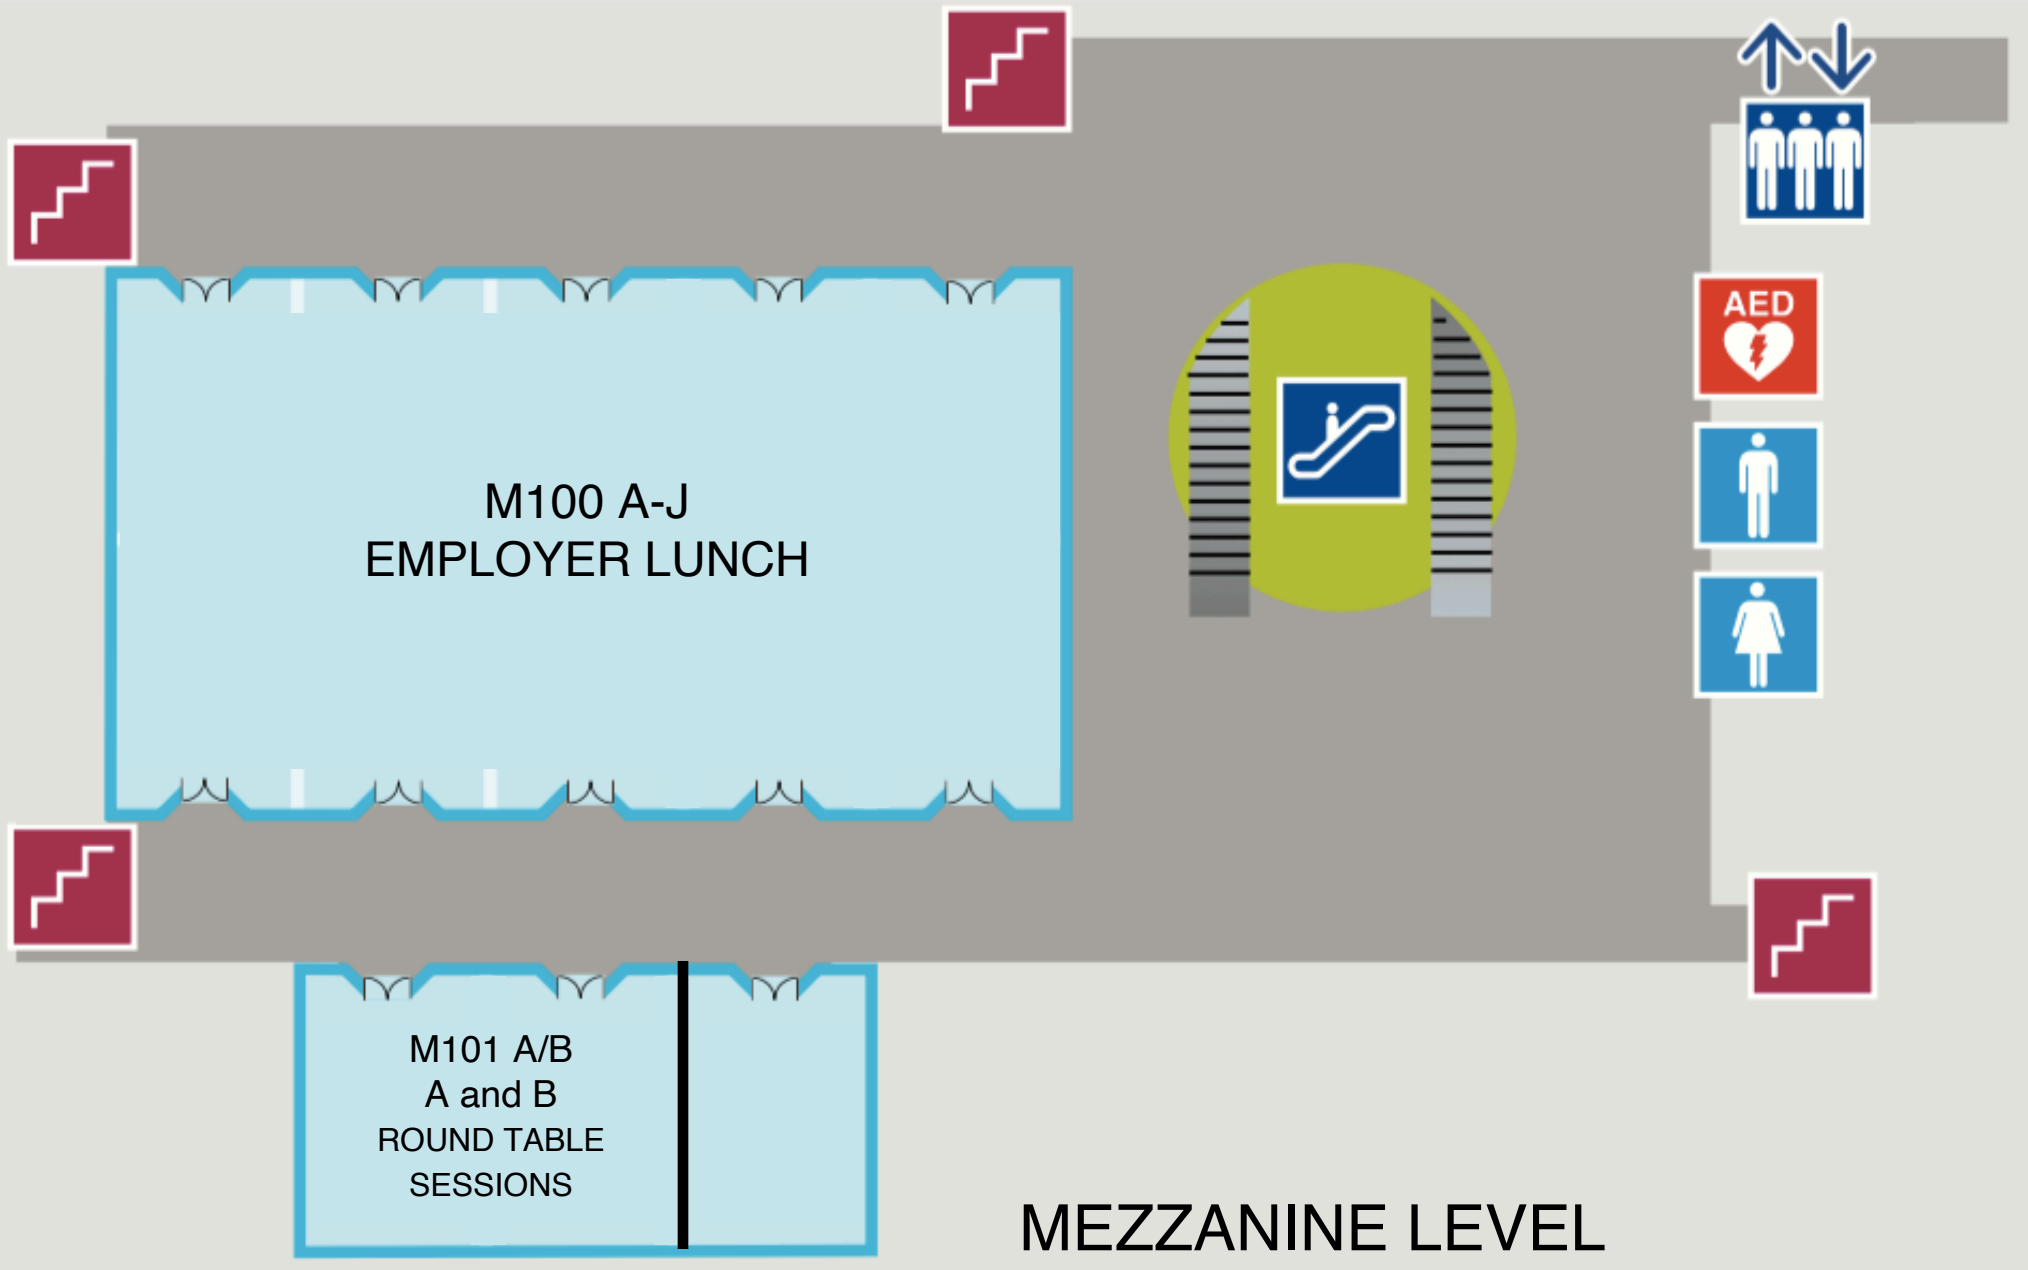

M100 A-J  
EMPLOYER LUNCH

M101 A/B  
A and B  
ROUND TABLE  
SESSIONS

MEZZANINE LEVEL

MINNESOTA PRIVATE COLLEGES