


Minneapolis Convention Center - Hall A

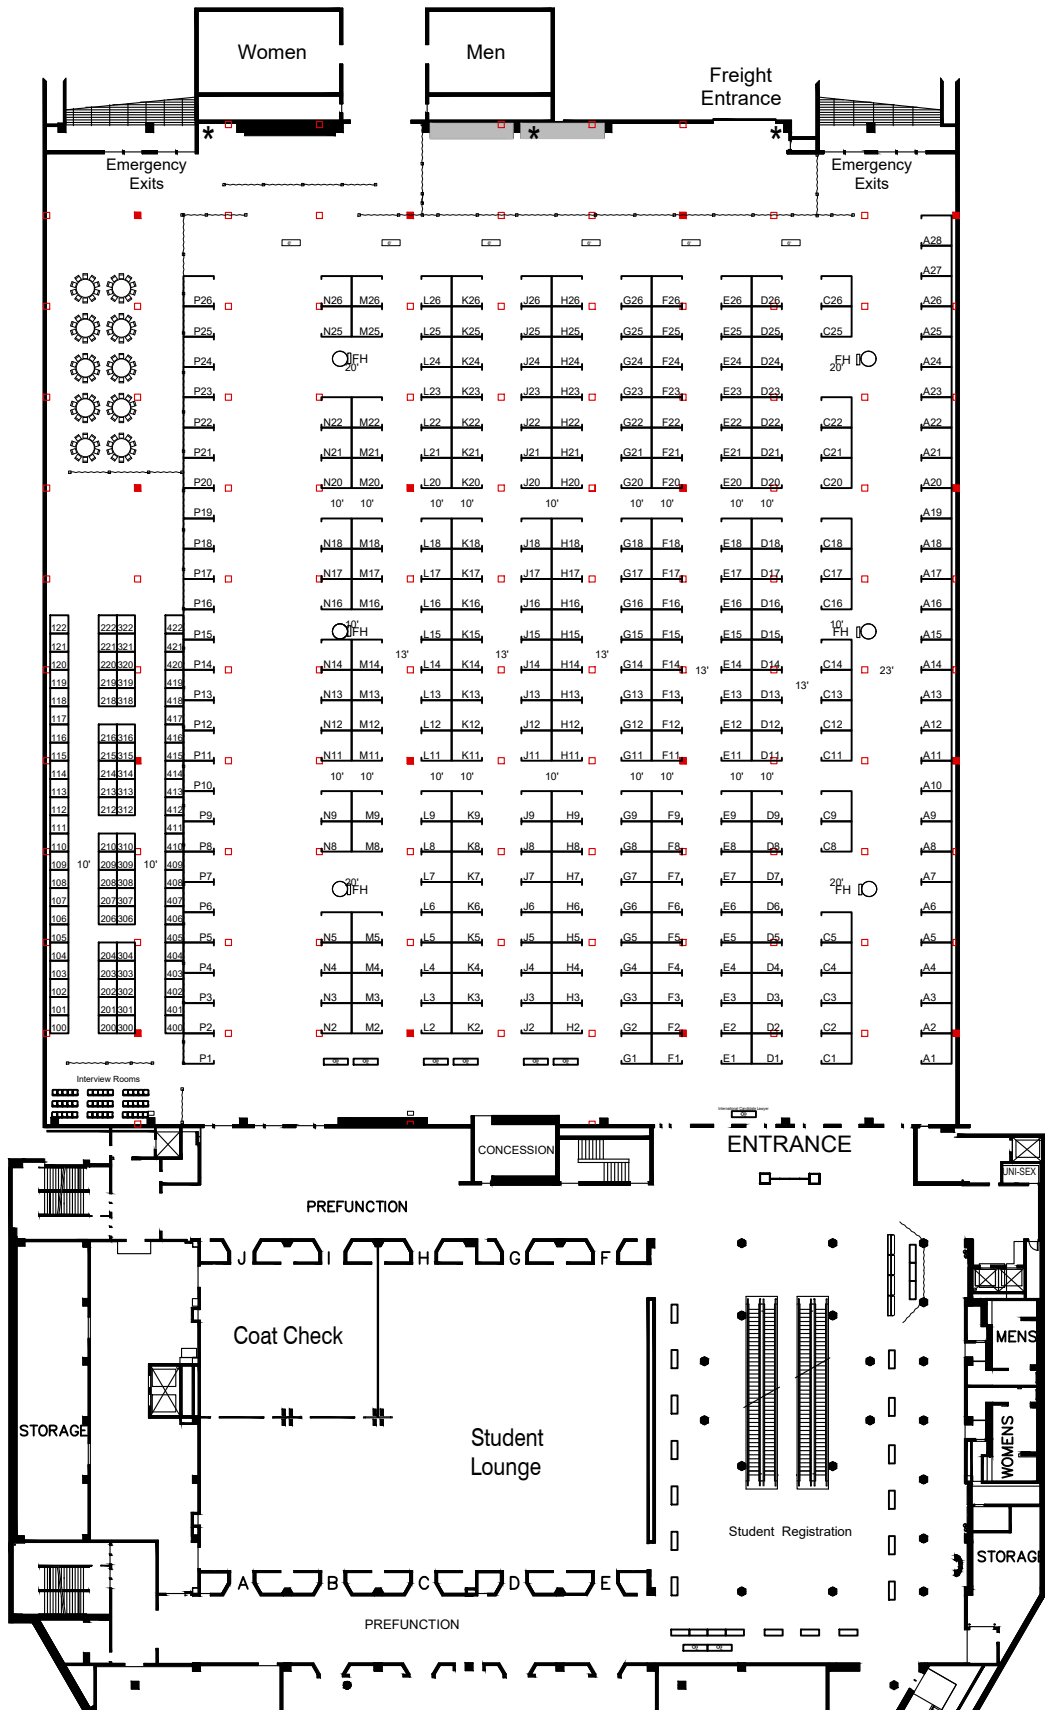

- LEGEND**
- FH - Fire Hose Cabinet
 - ▭ - 9'-6" Low Ceiling Height
 - ▭ - Required Safety Zone (Min. 15' Clearance)
 - - Electrical
 - - Electrical, Water & Drain
 - ★ - Gas Connection (back wall only)

Every effort has been made to ensure the accuracy of all information contained on this floor plan. However, no warranties, either expressed or implied are made with respect to this floor plan. If the location of building columns, utilities or other architectural components of the facility is a consideration in the construction of an exhibit, it is the sole responsibility of the exhibitor to physically inspect the facility to verify all dimensions and locations.

MN Private College Job&Internship

2/24/22

Facility: MN CC	Drawn By: Jocie Braaksma
City & State: Minneapolis, MN	Show Number: 13327-22
Room Location: Hall A And Lobby A	Revised: 12/14/2021 3:21 PM
A.E. Mike Marigold	Drawing File: 13327_22 MN Private College Job & Internship r2.dwg

Legend:

Dimension	Size	Qty	SqFt
6'x6'	36	86	3,096
10'x10'	100	297	29,700
Totals:	383	32,796	

