


# Minneapolis Convention Center - Hall A

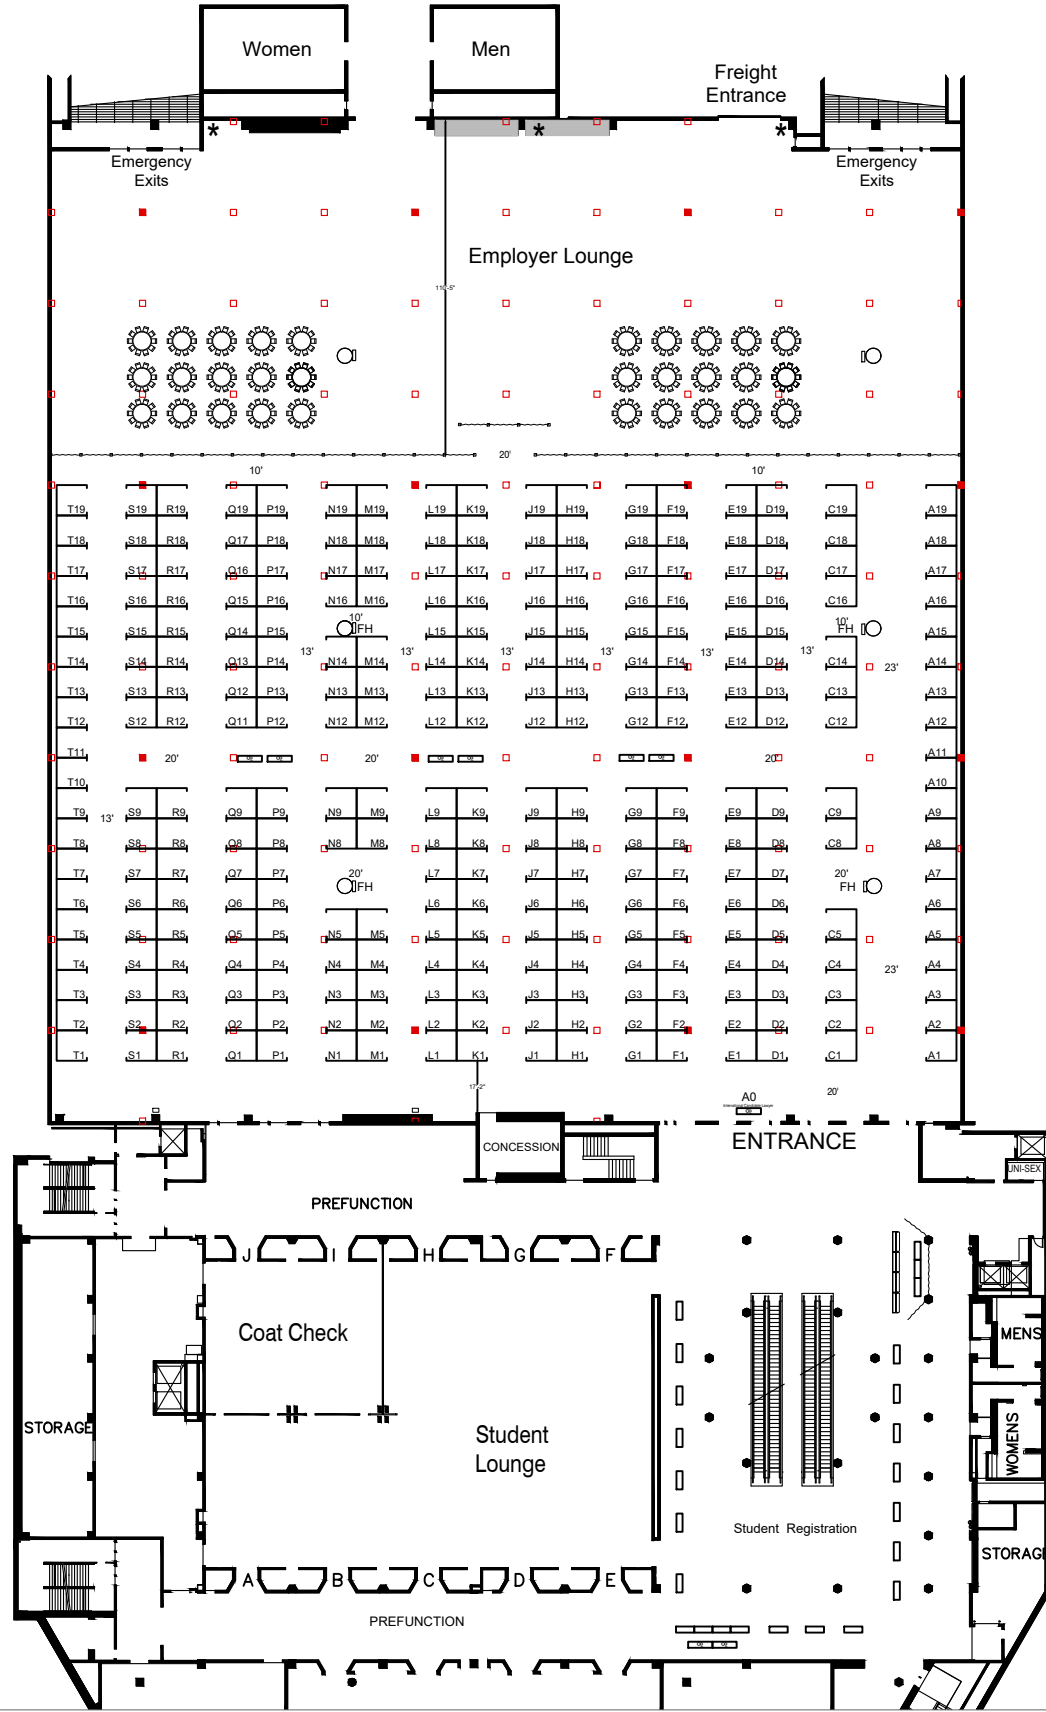

- LEGEND**
- FH - Fire Hose Cabinet
  - ▭ - 9'-6" Low Ceiling Height
  - ▭ - Required Safety Zone (Min. 15' Clearance)
  - - Electrical
  - - Electrical, Water & Drain
  - \* - Gas Connection (back wall only)

Every effort has been made to ensure the accuracy of all information contained on this floor plan. However, no warranties, either expressed or implied are made with respect to this floor plan. If the location of building columns, utilities or other architectural components of the facility is a consideration in the construction of an exhibit, it is the sole responsibility of the exhibitor to physically inspect the facility to verify all dimensions and locations.

## MN Private College Job & Internship Fair

### February 22, 2024

Facility: Minneapolis Convention Center	Drawn By: emostrom-ose
City & State: Minneapolis, MN	Show Number: 13327
Room Location: Hall A And Lobby A	Revised: 12/13/2023 2:10 PM
A.E. Mike Marigold	Drawing File: 13327_24_MN Private College Job & Intern.dwg

Legend:

Inventory as of 12/13/2023

Dimension	Size	Qty	SqFt
10'x10'	100	284	28,400
<b>Totals:</b>		<b>284</b>	<b>28,400</b>

